











Legend

-  Radiator
-  Towel heater
-  SVP
-  Gully
-  WF Wall mounted extract fan
-  F Ceiling mounted extract fan
-  Fan isolation switch
-  Area to be covered by carbon monoxide detector with remote indicator to L2 standard
-  Area to be covered by smoke detector with remote indicator to L2 standard
-  Rate of Rise Heat detector

Smoke detectors, Rate of Rise heat detectors and Carbon Monoxide detectors to be mains wired and interconnected



Direction of flow determined by drainage engineer.

Internal waste runs to SVPs, Gullies, etc. to connect to drainage system as designed by drainage engineer. Inspection chamber positions shown on this drawing are indicative and subject to change when U/G drainage design is complete.

Ground Floor Plan
Scale: 1:100



Lyndale | Harworth Road | Blyth
Workshop | S81 8HQ

t: 01909 591871 | m: 07828 789651
e: chrisyorke@btinternet.com

www.yorkearchitecture.com

Proposed Extension/Alterations

Top Farm
Rampton Road
Laneham
Refford
DN22 0NE

Project

Proposed Ground Floor Plan

PC493/06

Drawing

Date
18.01.2022

Drawn By
RH

Scale 1:100 Sheet Size A2








 


Revision
C

All dimensions given are to assist in the pricing of works. It is the responsibility of the person carrying out the works to verify all dimensions on site prior to placing orders or carrying out works.


Note



Legend

-  Radiator
-  Towel heater
-  SVP
-  Gully
-  Wall mounted extract fan
-  Ceiling mounted extract fan
-  Fan isolation switch
-  Area to be covered by carbon monoxide detector with remote indicator to L2 standard
-  Area to be covered by smoke detector with remote indicator to L2 standard
-  Rate of Rise Heat detector

Smoke detectors, Rate of Rise heat detectors and Carbon Monoxide detectors to be mains wired and interconnected

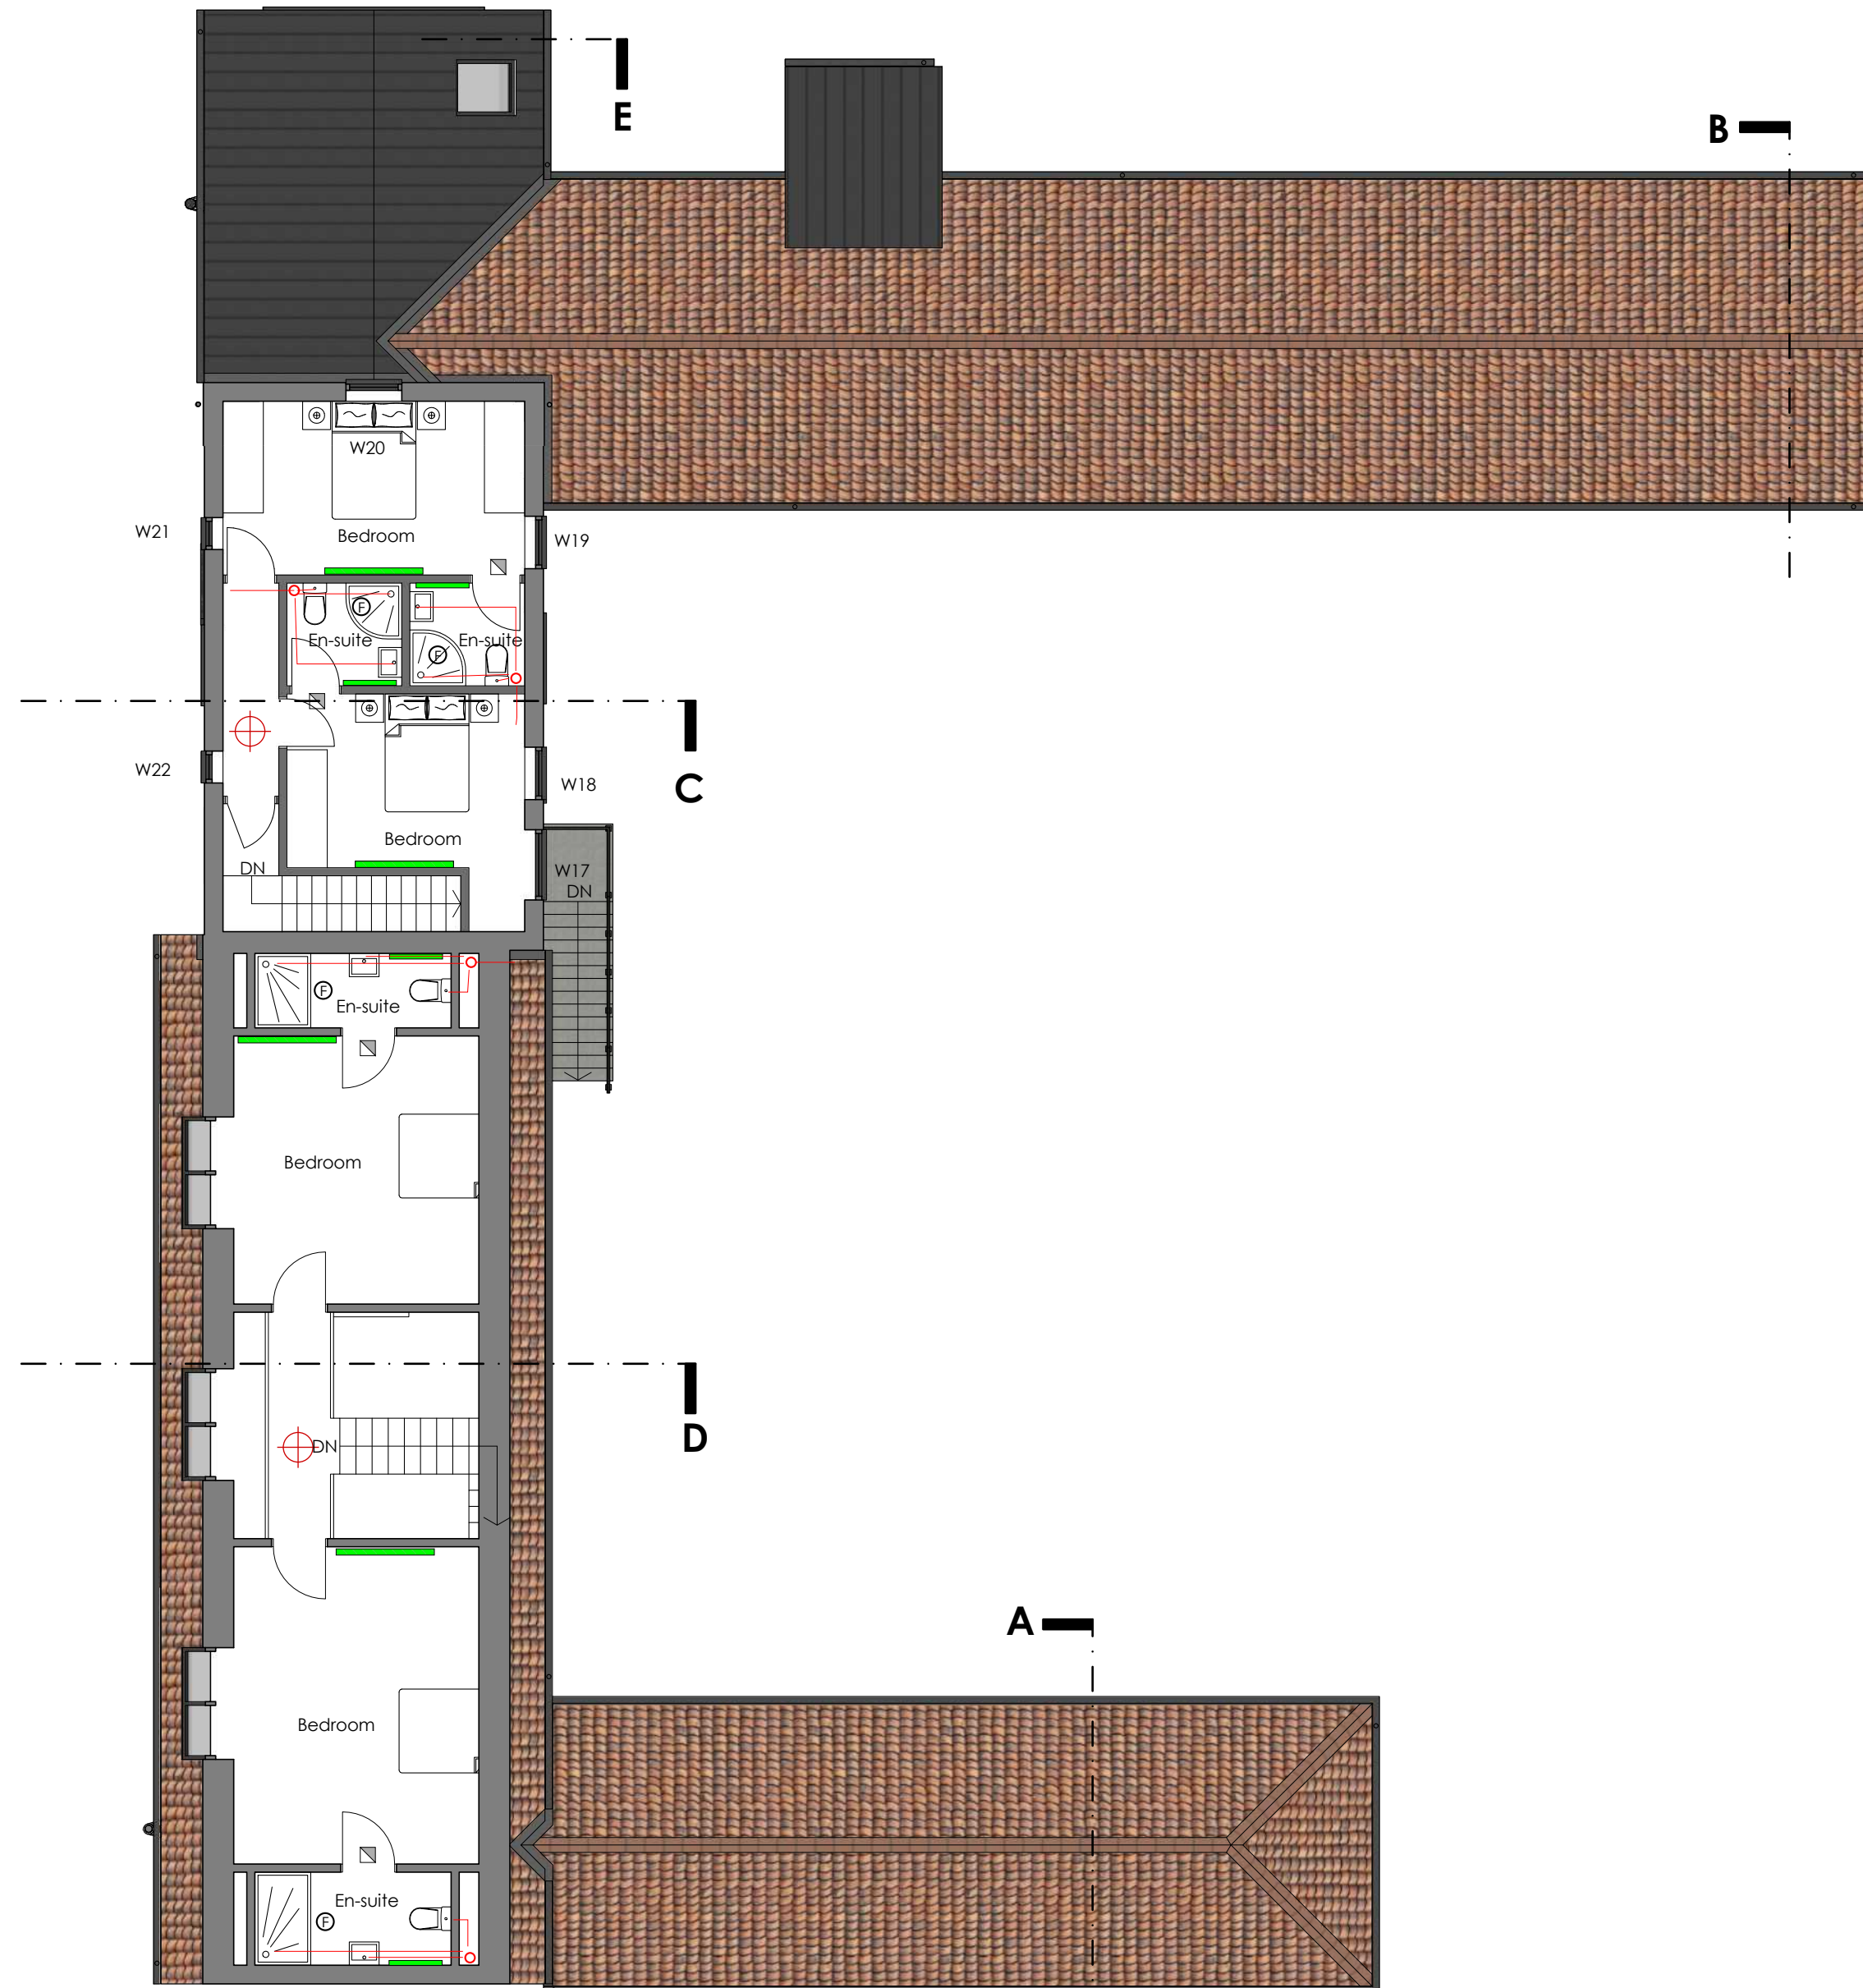

Ground Floor Plan
Scale: 1:100



Lyndale | Harworth Road | Blyth
Worksop | S81 8HQ

t: 01909 591871 | m: 07828 789651
e: chrisyorke@btinternet.com

www.yorkearchitecture.com

Proposed Extension/Alterations

Top Farm
Rampton Road
Laneham
Retford
DN22 0NE

Project

Proposed First Floor Plan

PC493/07

Drawing

Date
18.01.2022

Drawn By
RH

Scale 1:100 Sheet Size A2

Revision
C



All dimensions given are to assist in the pricing of works. It is the responsibility of the person carrying out the works to verify all dimensions on site prior to placing orders or carrying out works.

Note

